


ES-5 SWITCHMASTER

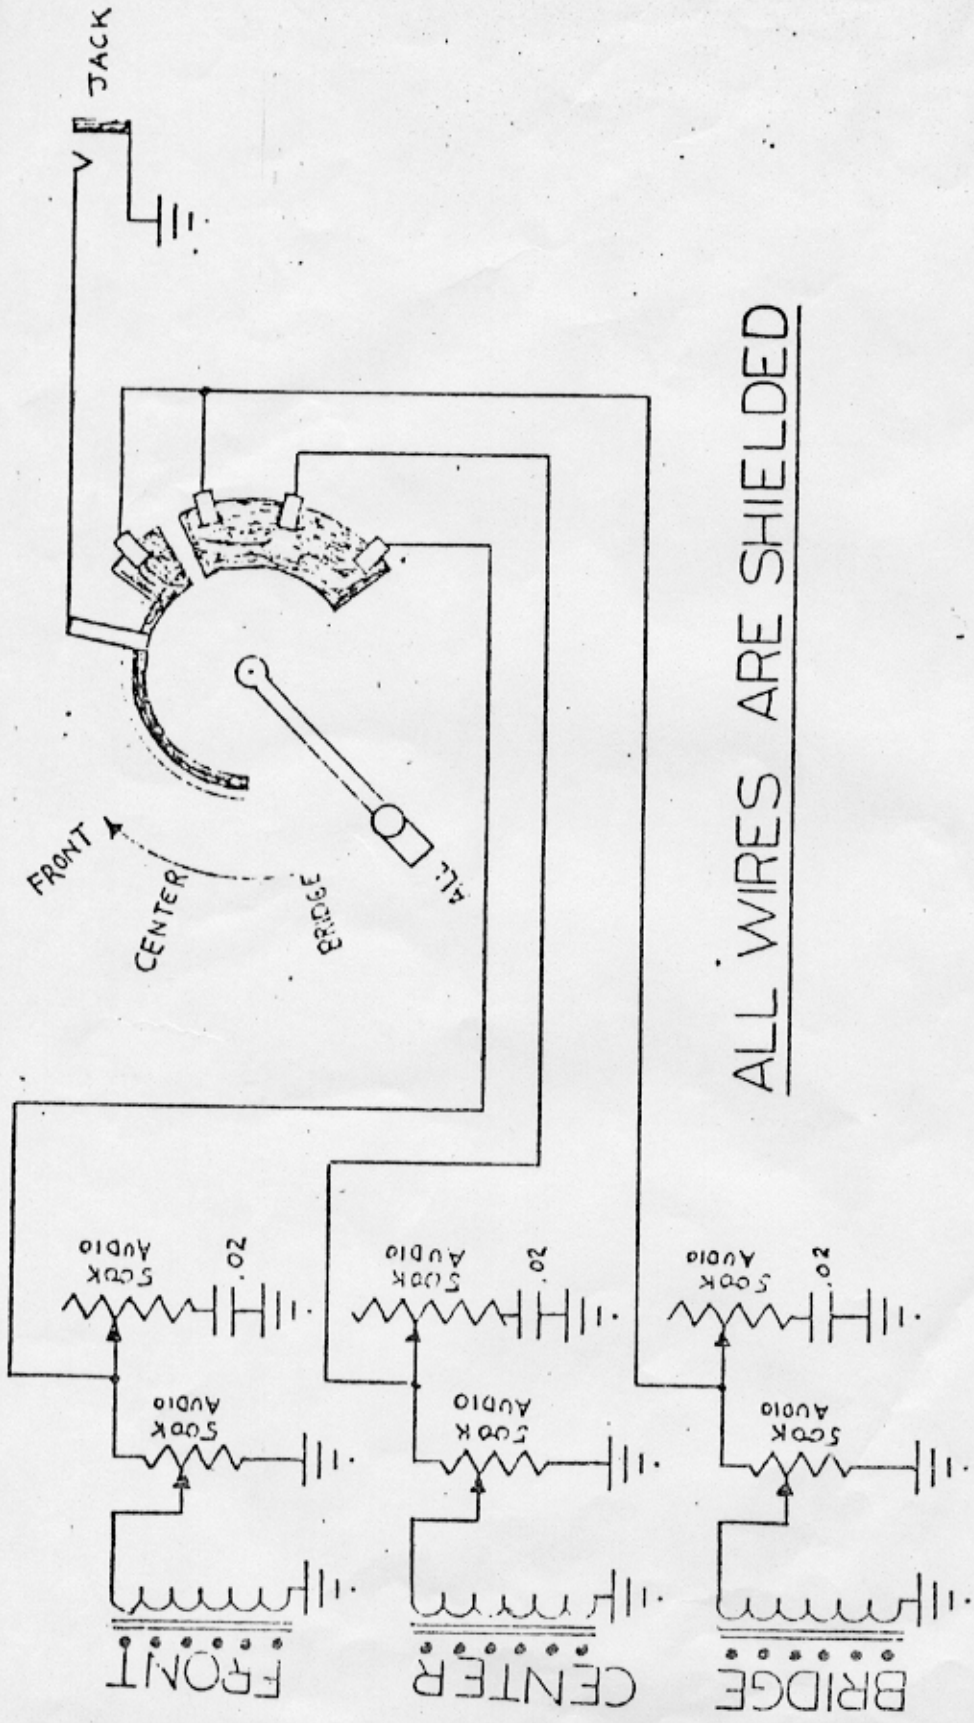

GIBSON INC.	Control Schematic
	ES-5 Switchmaster
2 Aug. 60	Drawn by M.D.